
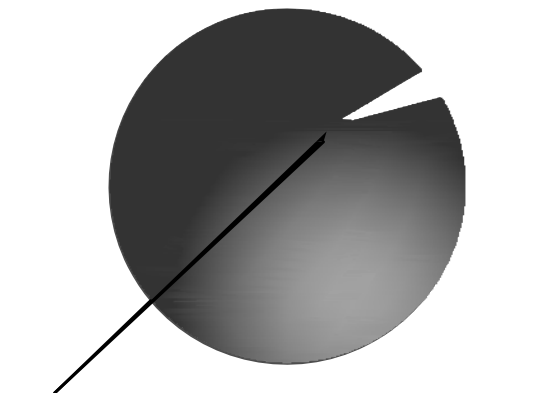
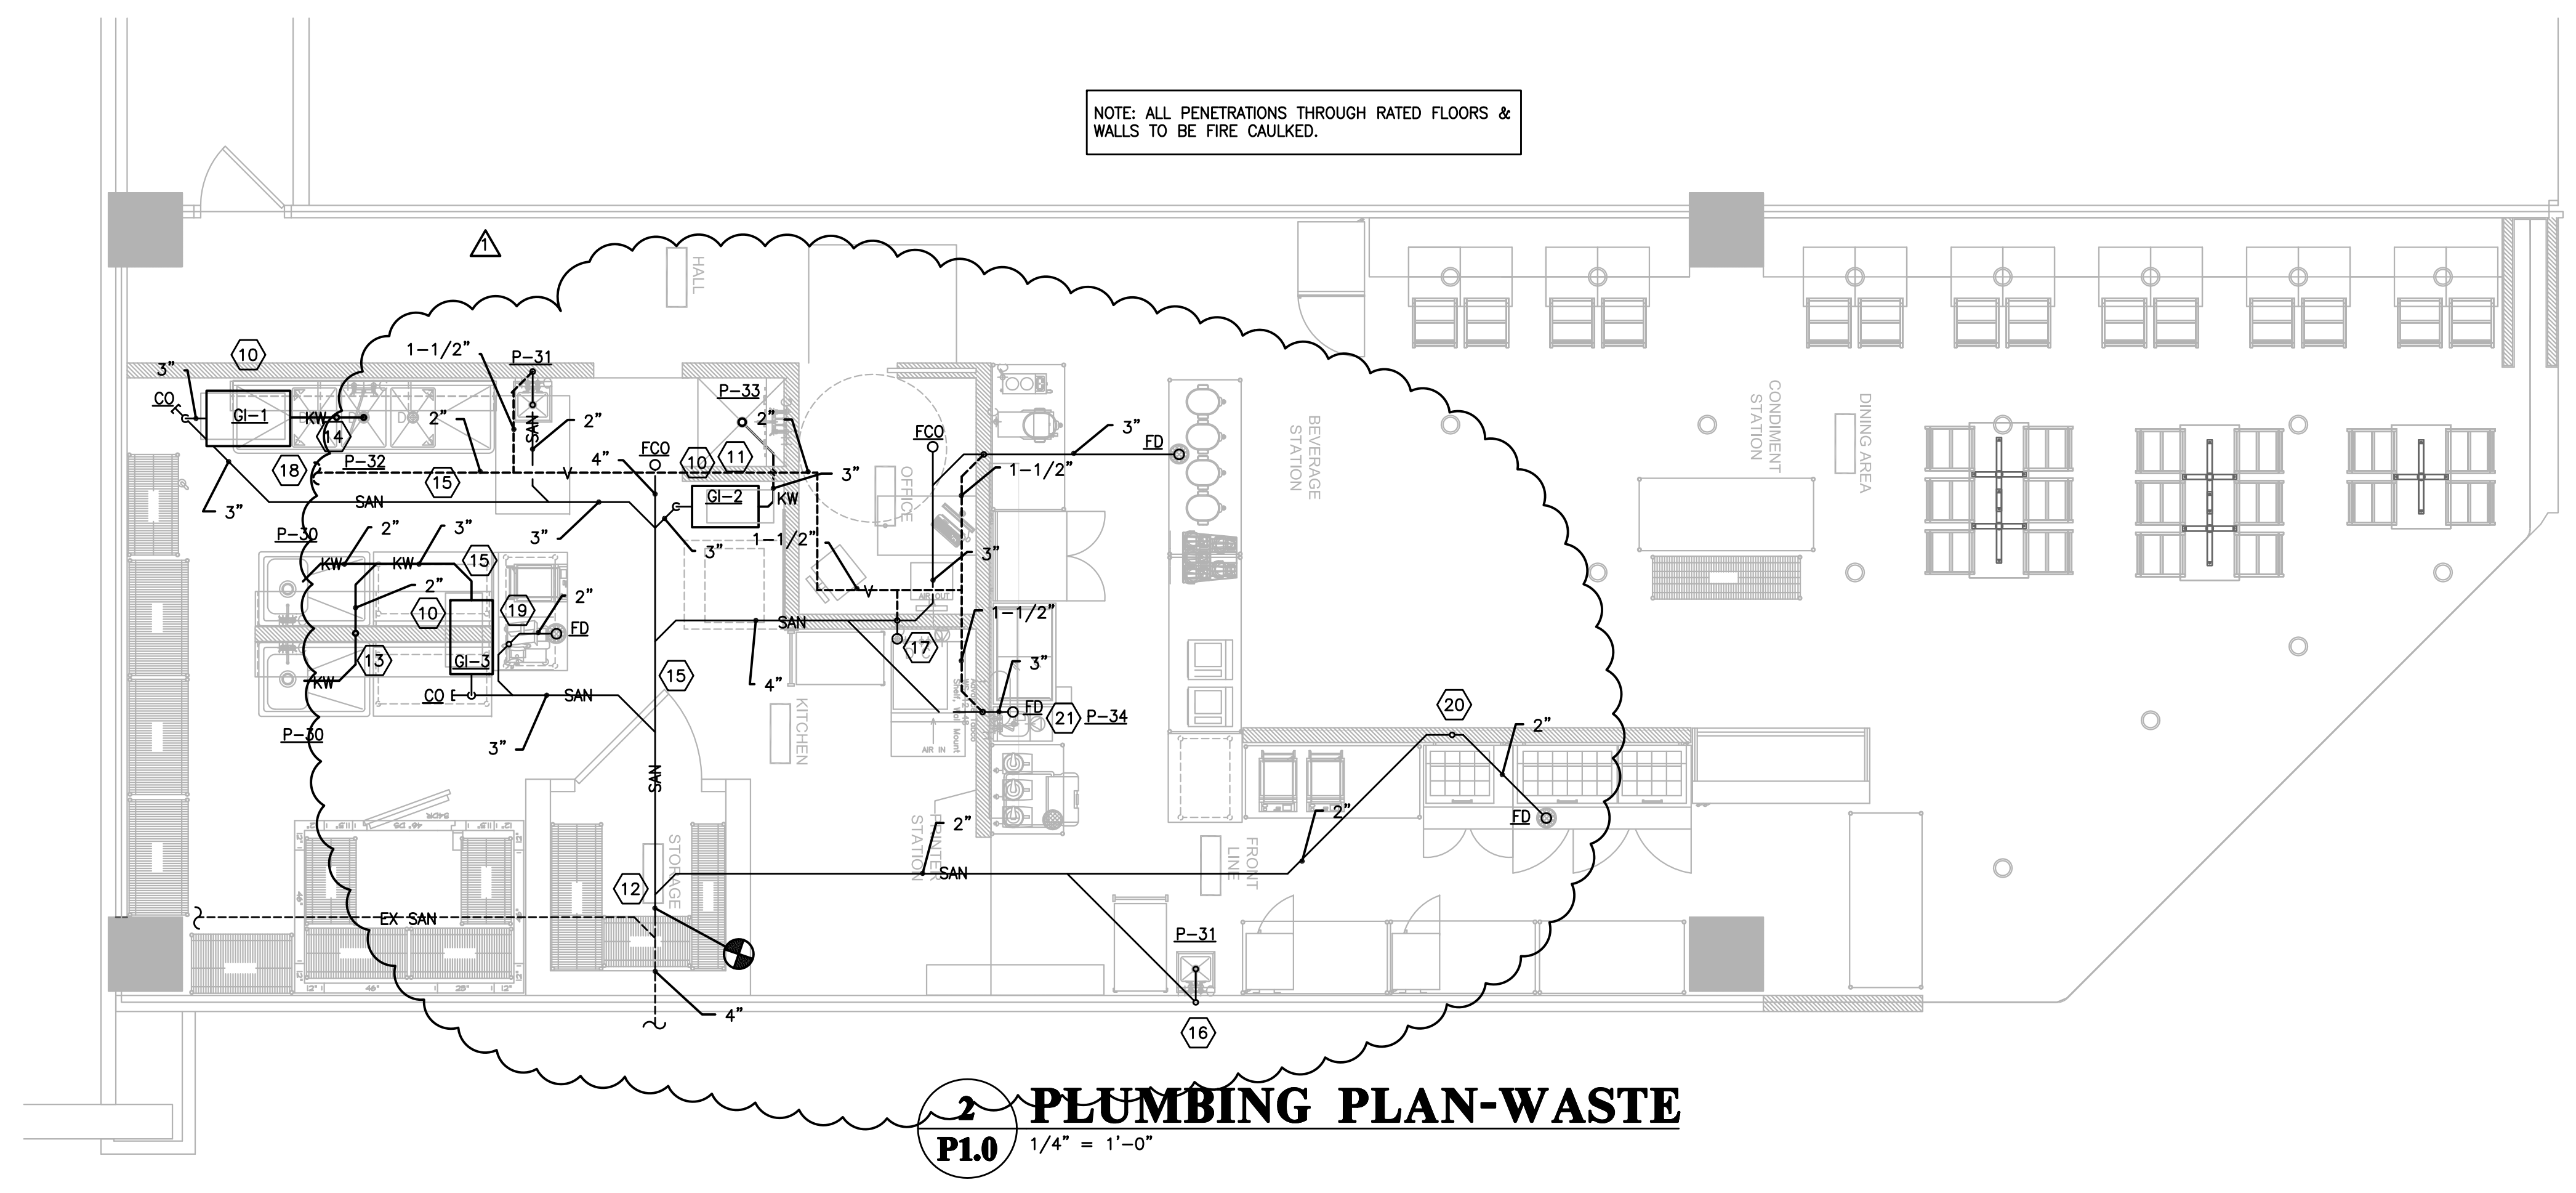


ALL DESIGNS, DRAWINGS AND SPECIFICATIONS DEPICTED ON THIS SHEET ARE THE PROPERTY OF THE RBA GROUP, INC. ANY UNAUTHORIZED USE OR REPRODUCTION IS SUBJECT TO LEGAL PROSECUTION. POSSESSION IN ANY FORM CONSTITUTES ACCEPTANCE OF THESE CONDITIONS. COPYRIGHT 2005

**KEYNOTES**

1. PROVIDE NEW VALVED 1-1/4" TAP IN EXISTING 2" COLD WATER LINE RUNNING ABOVE SPACE PER BUILDING AS BUILT DRAWINGS. FIELD VERIFY LOCATION AND SIZE. PROVIDE 1-1/4" WATER METER EQUAL TO HERSEY MODEL MVR160 WITH TRUREAD REMOTE READOUT. COORDINATE REMOTE READOUT LOCATION WITH OWNER.
2. PROVIDE 1-1/4" RPZ EQUAL TO WATTS MODEL 009. ROUTE DRAIN TO FLOOR SINK UNDER 3-COMP SINK.
3. 1/2" H&CW DOWN TO SINK OR LAVATORY.
4. 3/4" H&CW DOWN TO BACK TO BACK PREP SINKS. PROVIDE 1/2" SUPPLY FOR EACH PIECE OF EQUIPMENT.
5. 1" C & HW TO & FROM WH-1. SEE DETAIL ON SHEET P2.0. WATER HEATER MOUNTED ABOVE CAN WASH. PROVIDE 6' CLEAR ABOVE CAN WASH FOR MOP HANGER.
6. 1/2" H&CW DOWN TO CAN WASH.
7. 1/2" CW DOWN TO ICE MACHINE. PROVIDE BACKFLOW PREVENTER ON ICE MACHINE SUPPLY & WATER FILTER PER NCPC.
8. 1/2" CW DOWN TO COFFEE & TEA BREWERS. PROVIDE SUPPLY FOR EACH PIECE OF EQUIPMENT. PROVIDE BACKFLOW PREVENTER ON SUPPLY PER NCPC.
9. 1/2" CW DOWN TO CONVECTION OVEN. PROVIDE BACKFLOW PREVENTER ON SUPPLY PER NCPC.
10. POINT OF USE GREASE INTERCEPTOR TO BE FLOOR MOUNTED ALLOW 12" MINIMUM CLEAR FOR ACCESS ABOVE COVER.
11. RAISE CAN WASH ONLY AS MUCH AS NECESSARY TO ALLOW TRAPPED WASTE TO CONNECT INTO INTERCEPTOR INLET. ENCLOSE AREA BELOW BASIN WITH APPROVED FLASHING MATERIAL.
12. TIE NEW SANITARY LINE INTO EXISTING 4" CLEANOUT HERE.
13. PROVIDE 1-1/2" STUDOR VENT FOR PREP SINK DRAINS IN WALL. PROVIDE ACCESS GRILLE.
14. PROVIDE 1-1/2" STUDOR VENT UNDER SINK FOR 3 COMP DRAIN.
15. ALL HORIZONTAL LINES DENOTED SANITARY (SAN) ARE UNDER FLOOR. ALL KITCHEN WASTE LINES (KW) ARE ABOVE FLOOR.
16. PROVIDE 1-1/2" STUDOR VENT FOR HAND SINK WITH WALL ACCESS GRILLE ON KITCHEN SIDE OF WALL.
17. PROVIDE 2" TRAPPED OPEN HUB DRAIN ABOVE FLOOR FOR ICE MACHINE.
18. CONNECT NEW 2" VENT INTO EXISTING VENT. FIELD LOCATE.
19. PROVIDE 1-1/2" STUDOR VENT UNDER TABLE FOR FLOOR DRAIN.
20. PROVIDE 1-1/2" STUDOR VENT FOR FLOOR DRAIN IN WALL. PROVIDE ACCESS GRILLE.
21. DRAIN DUMP STATION & DIPWELL DRAIN INDIRECTLY INTO FLOOR DRAIN UNDER DUMP STATION.
22. 1/2" CW DOWN THRU WALL AND TERMINATE WITH VALVE 12" AFF FOR FUTURE ICE MACHINE SUPPLY UNDER WORK TABLES.

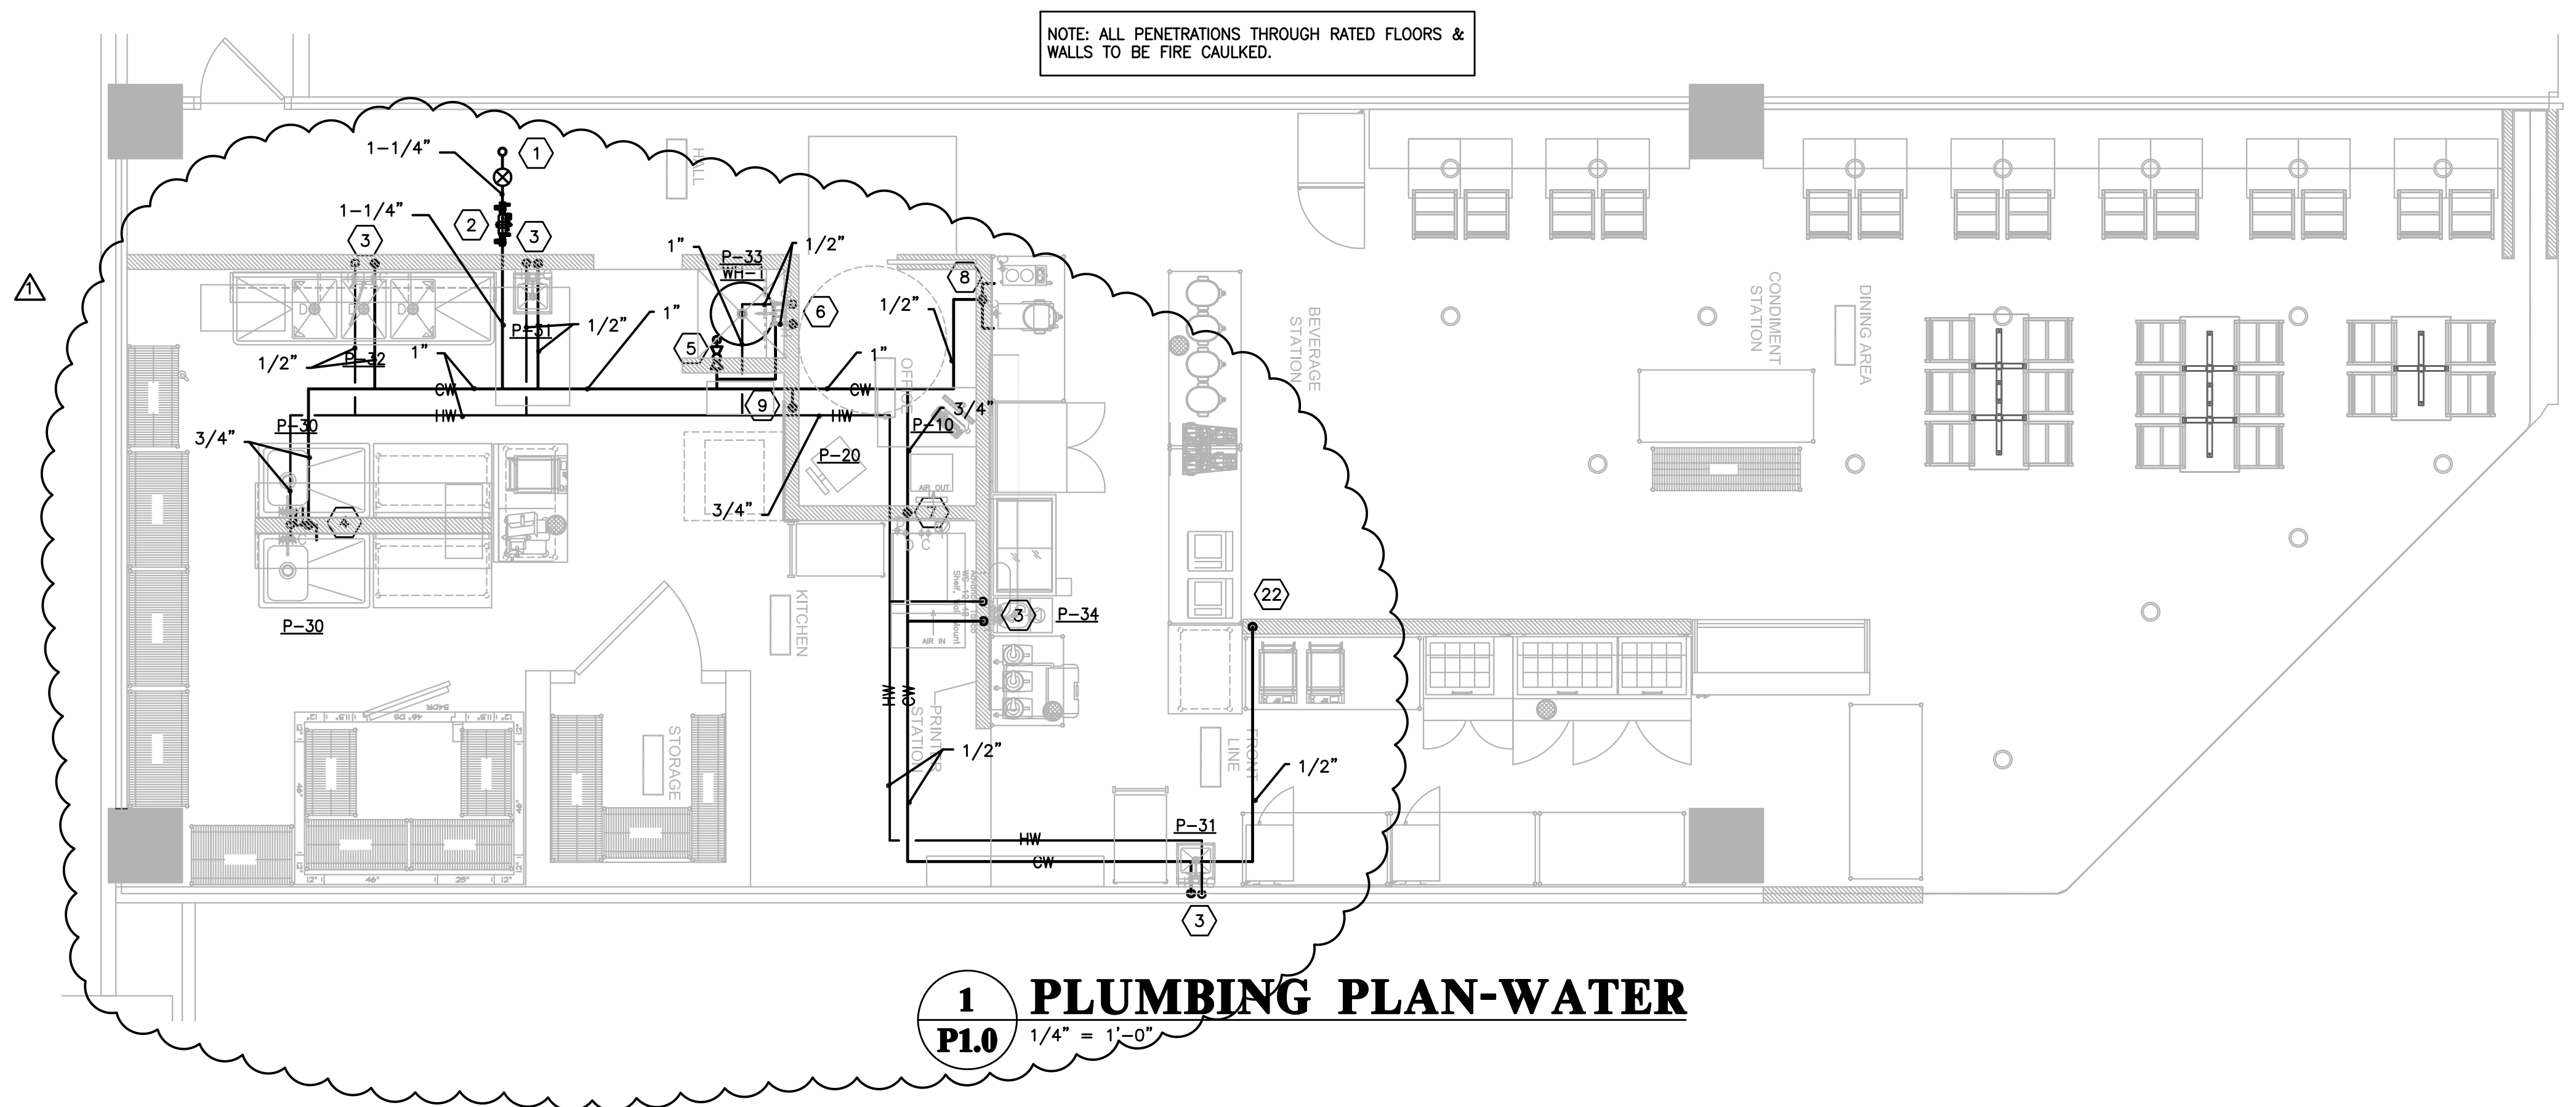

**RBA GROUP**  
ARCHITECTURE + INTERIORS  
1900 Abbott Street, Suite 101  
Charlotte, NC 28203  
O: 704.344.9098 F: 704.344.9099

**Signet Engineering**  
*(ig)<sup>ne</sup>*  
Your formula for engineering  
Suite 1025  
Charlotte, NC 28202  
704.336.5917 704.336.5996 fax  
License No. C-1000



OCTANE CAFE'  
OVERSTREET MALL  
CHARLOTTE, NC

101 SOUTH TRYON ST  
SUITE 1  
CHARLOTTE, NC 28202

| REVISION                 | DATE   |
|--------------------------|--------|
| 1<br>REVISIONS PER OWNER | 7.1.09 |

|                |         |
|----------------|---------|
| DRAWN BY       | RSM     |
| CHECKED BY     | RSM     |
| CONTRACT DATE  | 5.15.09 |
| PROJECT NUMBER |         |

PLUMBING PLAN

**P1.0**